



First floor  
Existing washroom layout

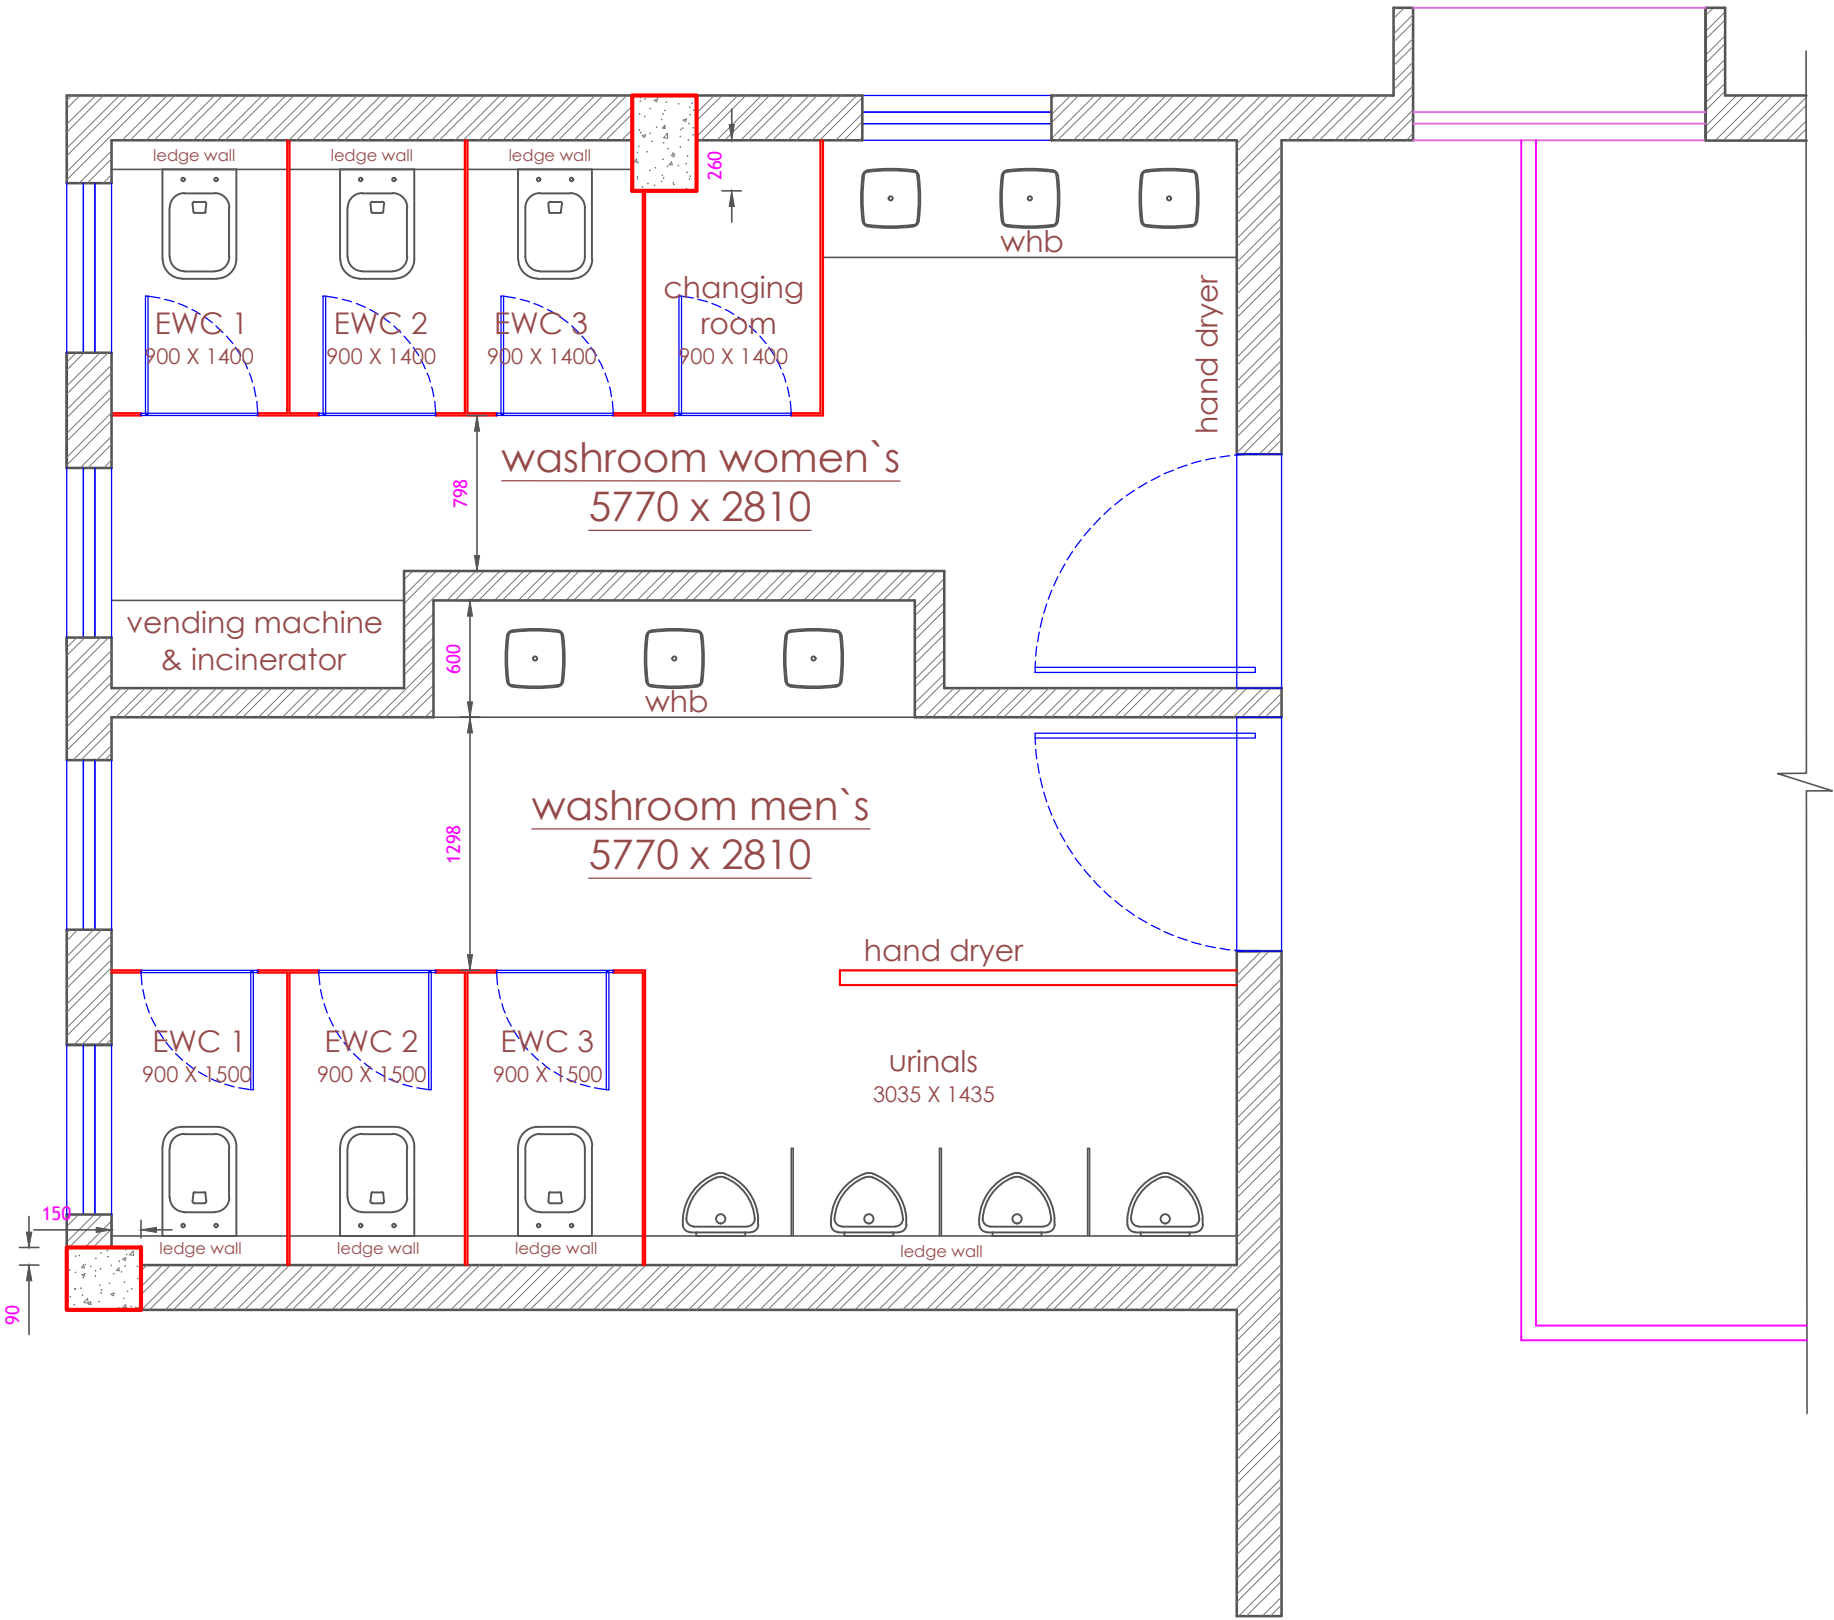

First floor plan  
Proposed Working Drawing

COMP DETAIL	PROJECT: PROPOSED WASHROOM RENOVATION AT WELINGKAR INSTITUTE OF MANAGEMENT DEVELOPMENT & RESEARCH AT L.N.ROAD, MATUNGA(EAST), MUMBAI - 400 019.				DESIGNED BY  KAILASH SONTAKKE REGD ARCHITECT CA 84-8700  TEL:020 2553 5436. EMAIL: kaison.144@gmail.com / kailash@assoarch.com  THIS DRG & THE CONNECTED DESIGN IS OUR SOLE PROPERTY & COPYRIGHT IT IS LOANED ON CONDITION OF RETURN ON DEMAND IT SHALL NOT BE COPIED LENT OR USED WITHOUT OUR PRIOR WRITTEN CONSENT	<div>ASSOCIATED ARCHITECTS</div> <div>SINCE 1983</div> <div></div>
	FOR: SHIKSHAN PRASARAK MANDALI, PUNE.					
	DRAWING: WASHROOM - WORKING DRAWING					
SCALE	JOB NO.	DRG. NO.	DATE	DRAWN BY.		
		130625-03	130625	MRUNALI		