



Second & Third floor
Existing washroom layout

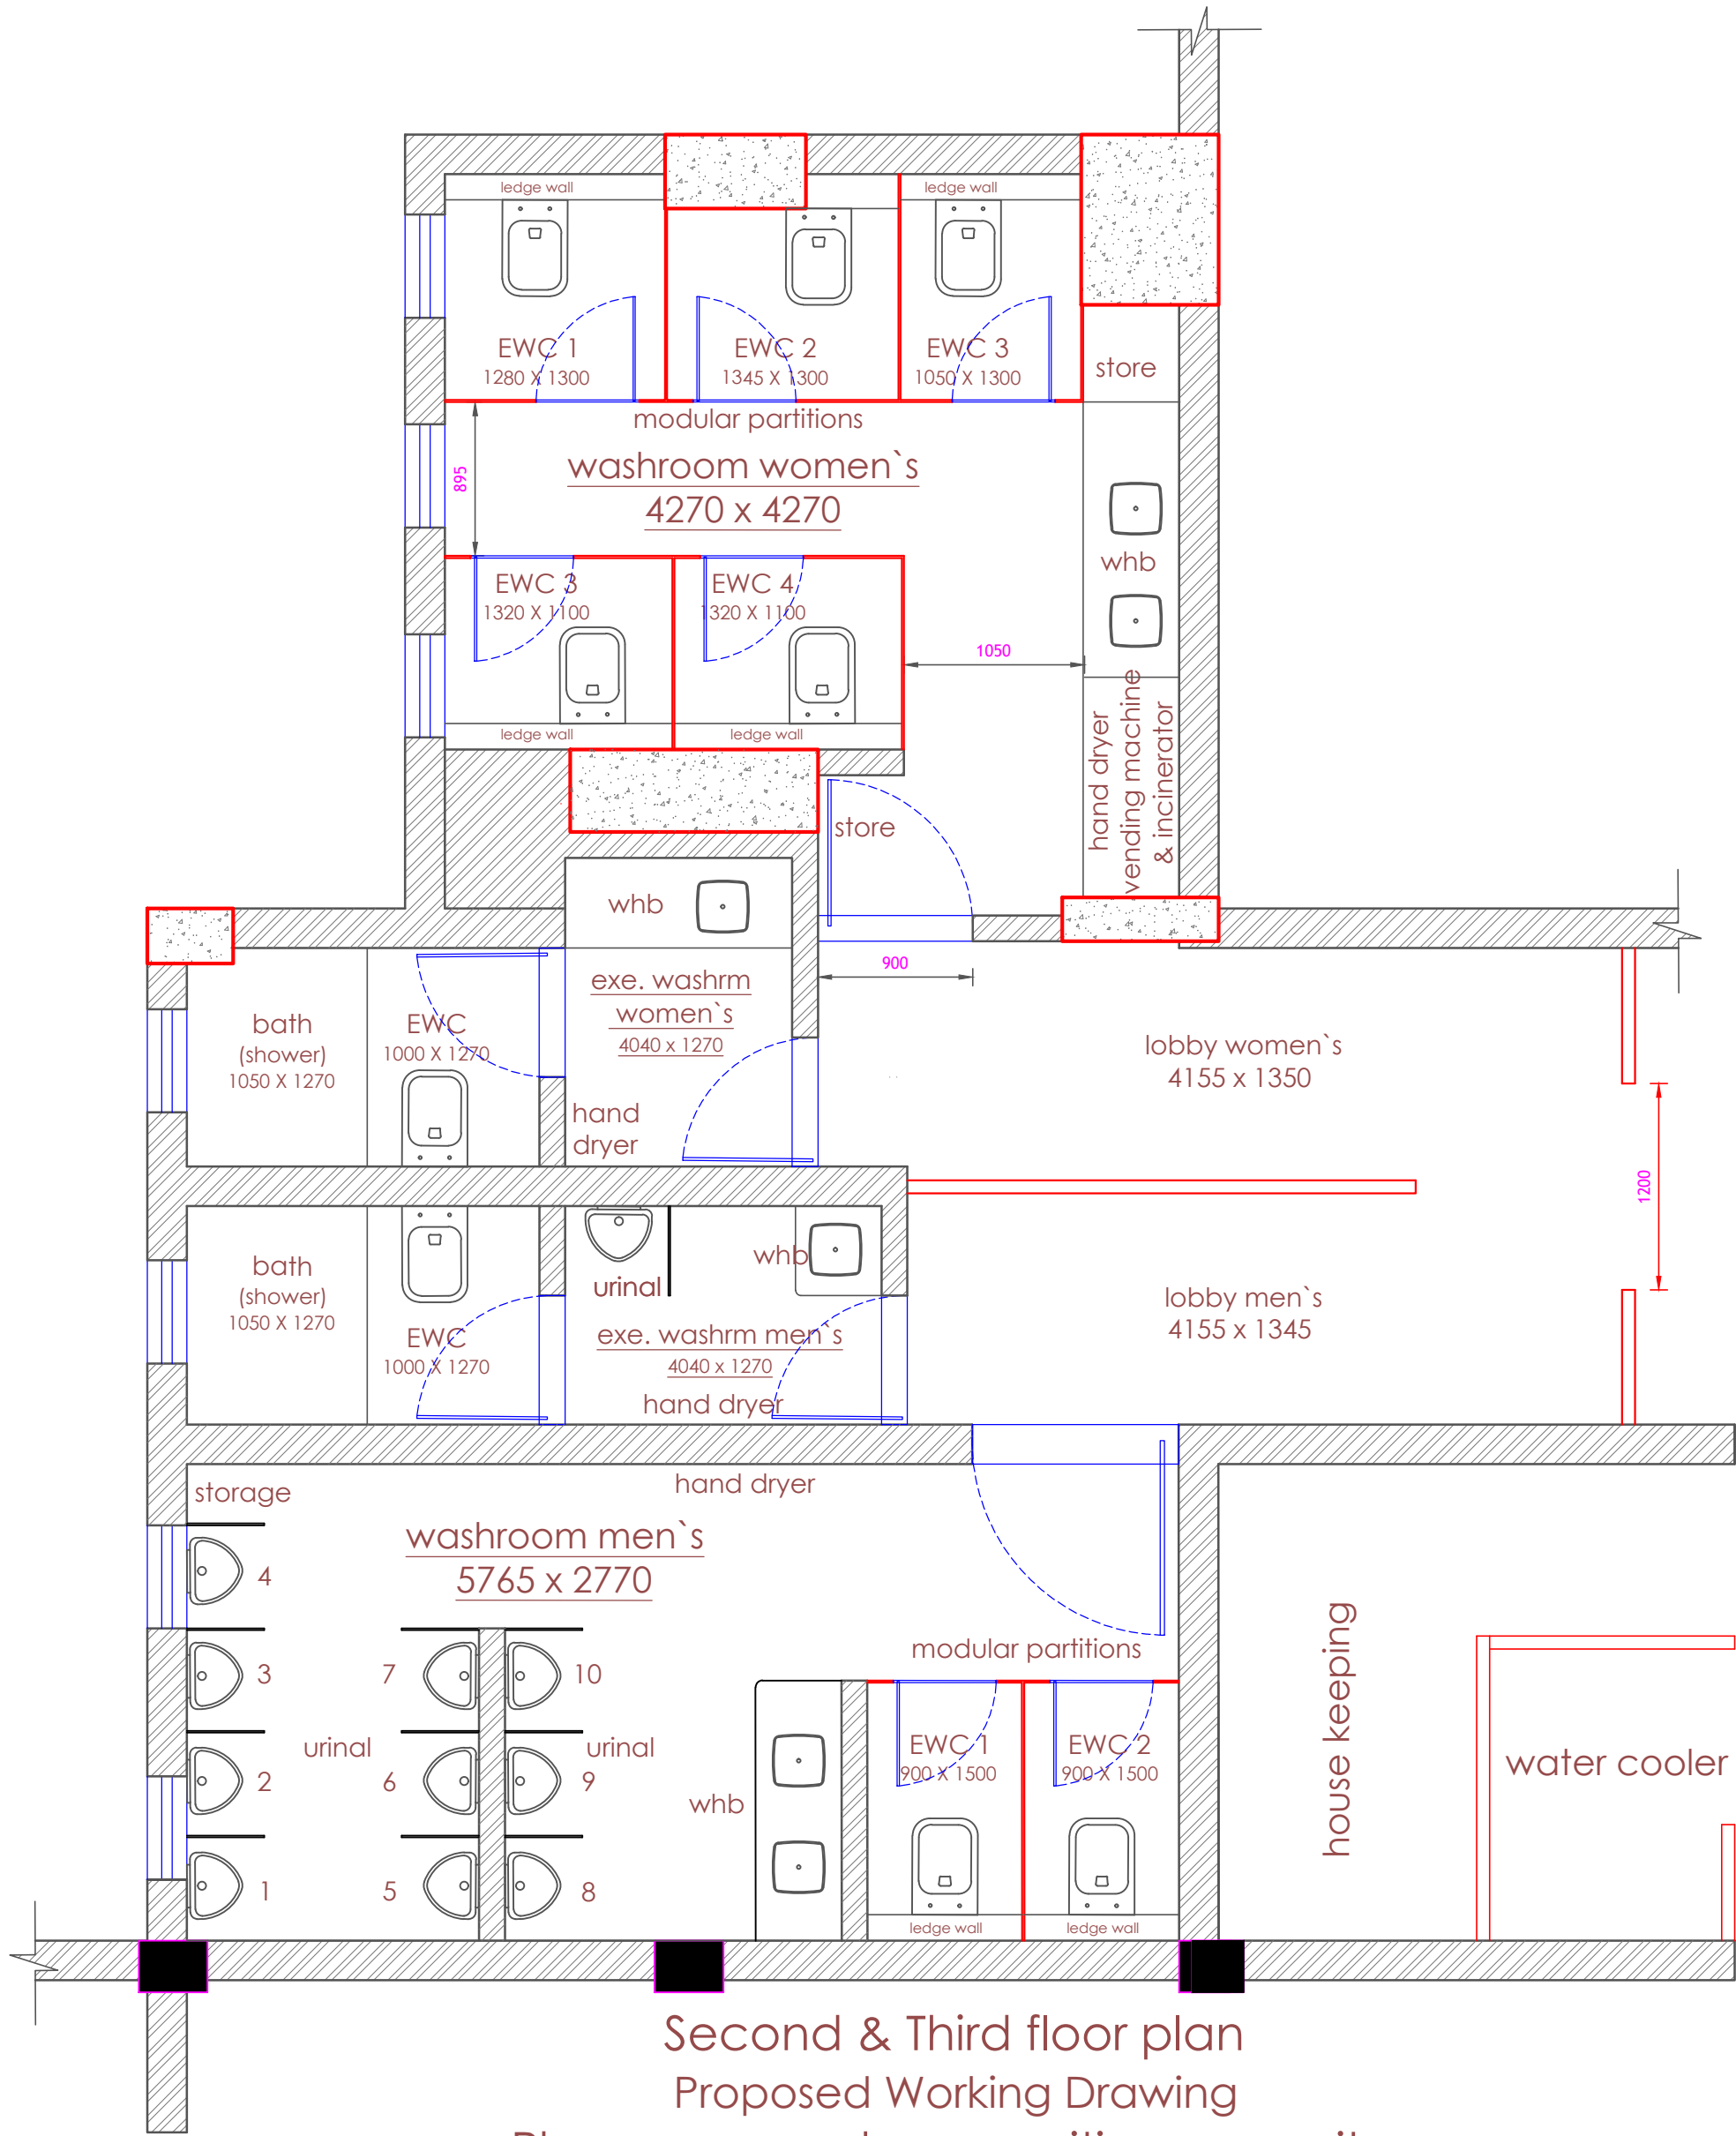

Second & Third floor plan
Proposed Working Drawing
Plans as per column position as on site

COMP DETAIL	PROJECT: PROPOSED WASHROOM RENOVATION AT WELINGKAR INSTITUTE OF MANAGEMENT DEVELOPMENT & RESEARCH AT L.N.ROAD, MATUNGA(EAST), MUMBAI - 400 019.				DESIGNED BY KAILASH SONTAKKE REGD ARCHITECT CA 84-8700 TEL:020 2553 5436. EMAIL: kaison.144@gmail.com / kailash@assoarch.com	<div>ASSOCIATED ARCHITECTS</div> <div>SINCE 1983</div> <div></div>
	FOR: SHIKSHAN PRASARAK MANDALI, PUNE.					
	DRAWING: WASHROOM - WORKING DRAWING					
SCALE	JOB NO.	DRG. NO.	DATE	DRAWN BY.	THIS DRG & THE CONNECTED DESIGN IS OUR SOLE PROPERTY & COPYRIGHT IT IS LOANED ON CONDITION OF RETURN ON DEMAND IT SHALL NOT BE COPIED LENT OR USED WITHOUT OUR PRIOR WRITTEN CONSENT	
		130625-04	130625	MRUNALI		